

NOTES:

1. THE ENTIRE CONDUIT, CABLE TRAY AND SLEEVE INFRASTRUCTURE FOR THE VOICE AND DATA INSTALLATION WILL BE DONE BY THE ELECTRICAL CONTRACTOR.

2. THE ELECTRICAL CONTRACTOR WILL SUPPLY AND INSTALL ALL RECESSED RJ45 VOICE AND DATA OUTLET POINTS.

3. THE VOICE AND DATA CONTRACTOR MUST CO-ORDINATE WITH THE ELECTRICAL CONTRACTOR WHICH SLEEVES CAN BE USED FOR THE VOICE AND DATA INSTALLATION. ANY SLEEVES AS PROVIDED FOR OTHER SERVICES THAN VOICE AND DATA CABLING MAY NOT BE USED BY THE VOICE AND DATA CONTRACTOR.

4. ALL SLEEVES INSIDE THE BUILDINGS AS SUPPLIED BY THE ELECTRICAL CONTRACTOR WILL BE COMPLETE WITH DRAW WIRES.

THIS DRAWING IS TO BE READ IN CONJUNCTION WITH THE FOLLOWING ENGINEERING SERVICE ONLY:

VOICE & DATA INSTALLATION

NO.	REVISIONS	APPROVED	DATE

CLIENT

MINISTRY OF WORKS AND TRANSPORT

REPUBLIC OF NAMIBIA

MMT HEAD OFFICE BUILDING  
6719 BELL ST SWANMAN CIRCLE  
WINDHÖCK

TEL: (061) 208 811  
FAX: (061) 224 381

PRIVATE BAG 13341  
WINDHÖCK

APPROVED

COPYRIGHT RESERVED

DATE

CONSULTANTS

ARCHITECT  
CLARKE ARCHITECTS

P.O. BOX 35154  
WINDHÖCK  
NAMIBIA

TEL: (061) 401 428  
FAX: (061) 401 408  
email: [clarke@clarke-architects.com](mailto:clarke@clarke-architects.com)

QUANTITY SURVEYOR  
BLOKKER JACOBS & KUSCHKE QUANTITY SURVEYORS

P.O. BOX 97015  
MARITIA PARK  
WINDHÖCK

TEL: (061) 225 739  
FAX: (061) 234 622  
email: [jku@afrika.com.na](mailto:jku@afrika.com.na)

CIVIL & STRUCTURAL ENGINEER  
WML COAST CONSULTING ENGINEERING

P.O. BOX 2772  
SWAKOPMUND  
NAMIBIA

TEL: (064) 405 600  
FAX: (064) 405 599  
email: [wml@wml.com.na](mailto:wml@wml.com.na)

ELECTRICAL AND MECHANICAL ENGINEERS

G.S. FAINSDINGER & ASSOCIATES  
Consulting Engineers

P.O. BOX 2142  
32 BISMARCK STREET  
WINDHÖCK  
NAMIBIA

TEL: +26461 235 165  
FAX: +26461 235 166  
E-MAIL: [gfa@ggfa.com.na](mailto:gfa@ggfa.com.na)

PROJECT

CONSTRUCTION OF NEW REGIONAL MICT OFFICES IN MARIENTAL, HARDAP REGION

DRAWING TITLE

VOICE AND DATA SITE PLAN

ELECTRICAL INSTALLATION

CONSULTANT PROJECT NO.: 5280

DESIGNED: SWPL

DRAWN: HVZ




CHECKED: ES

SCALE: 1:200

DATE: 09/03/2016

DRAWING NO.: 5280/1001/EE-VD

VO: 00

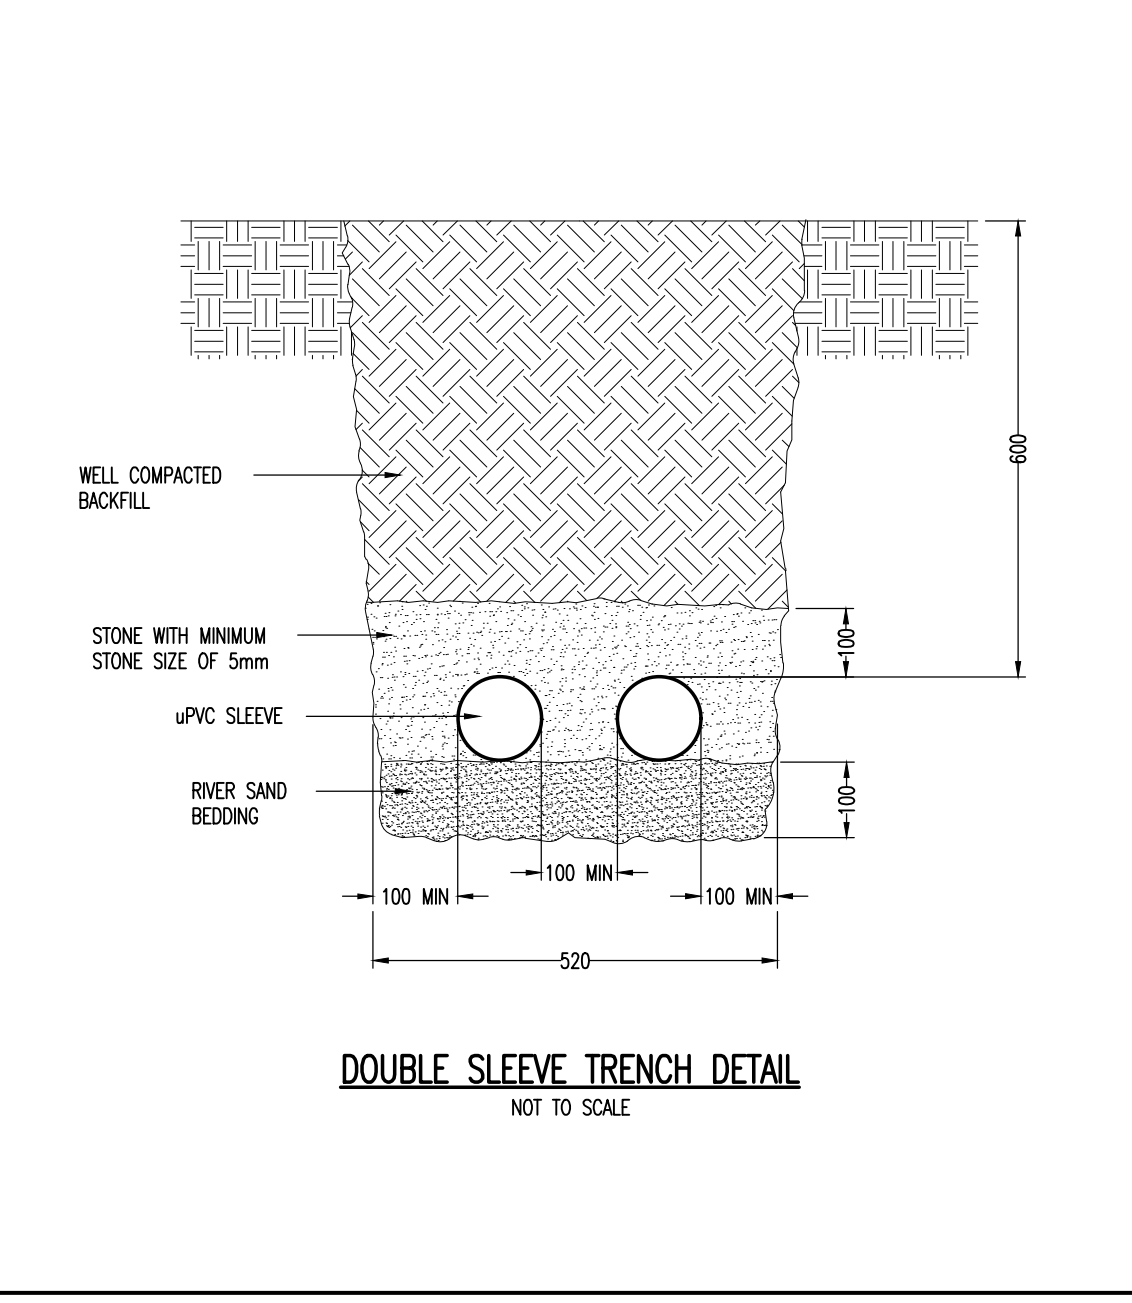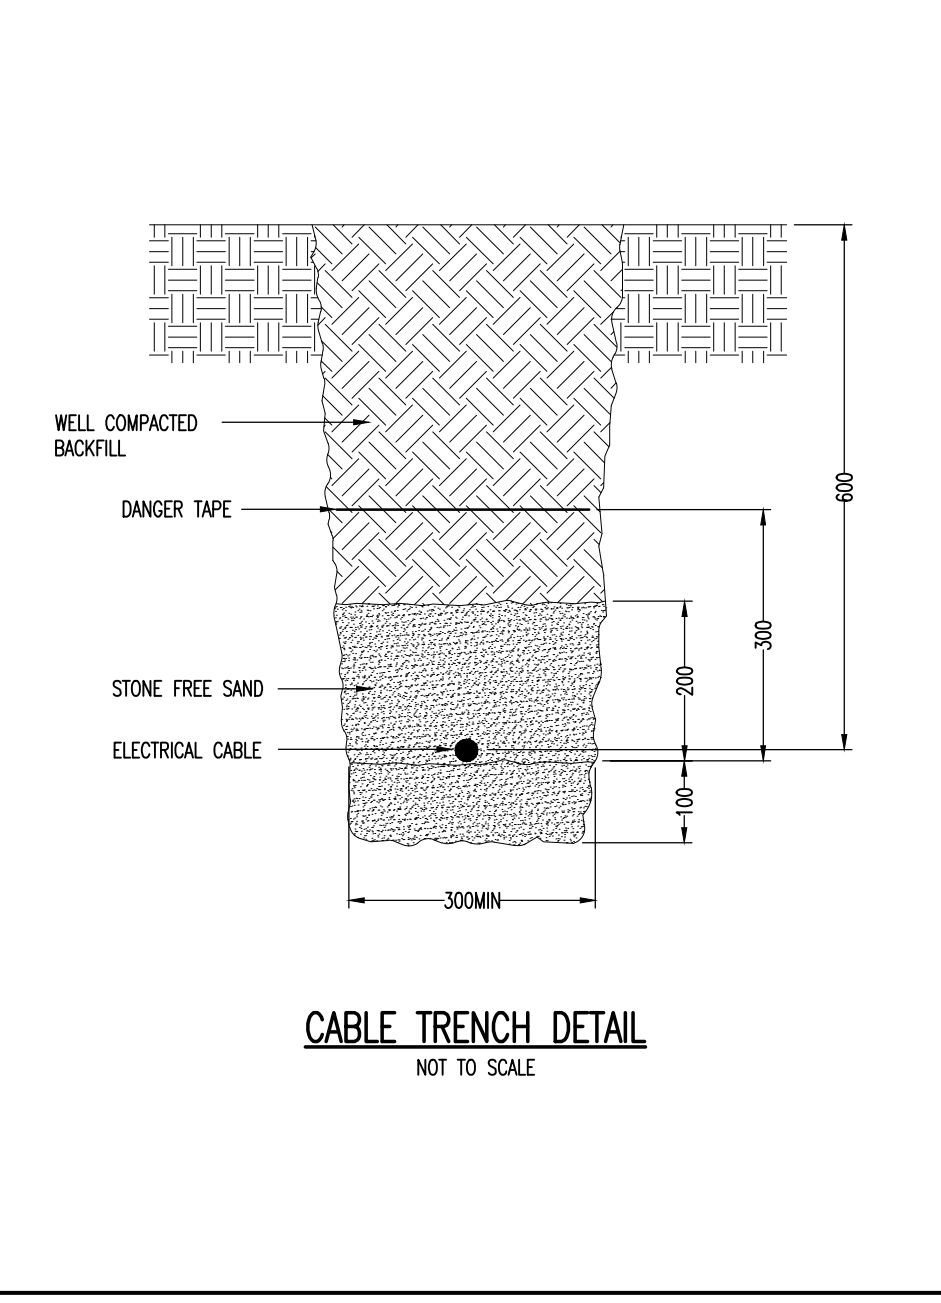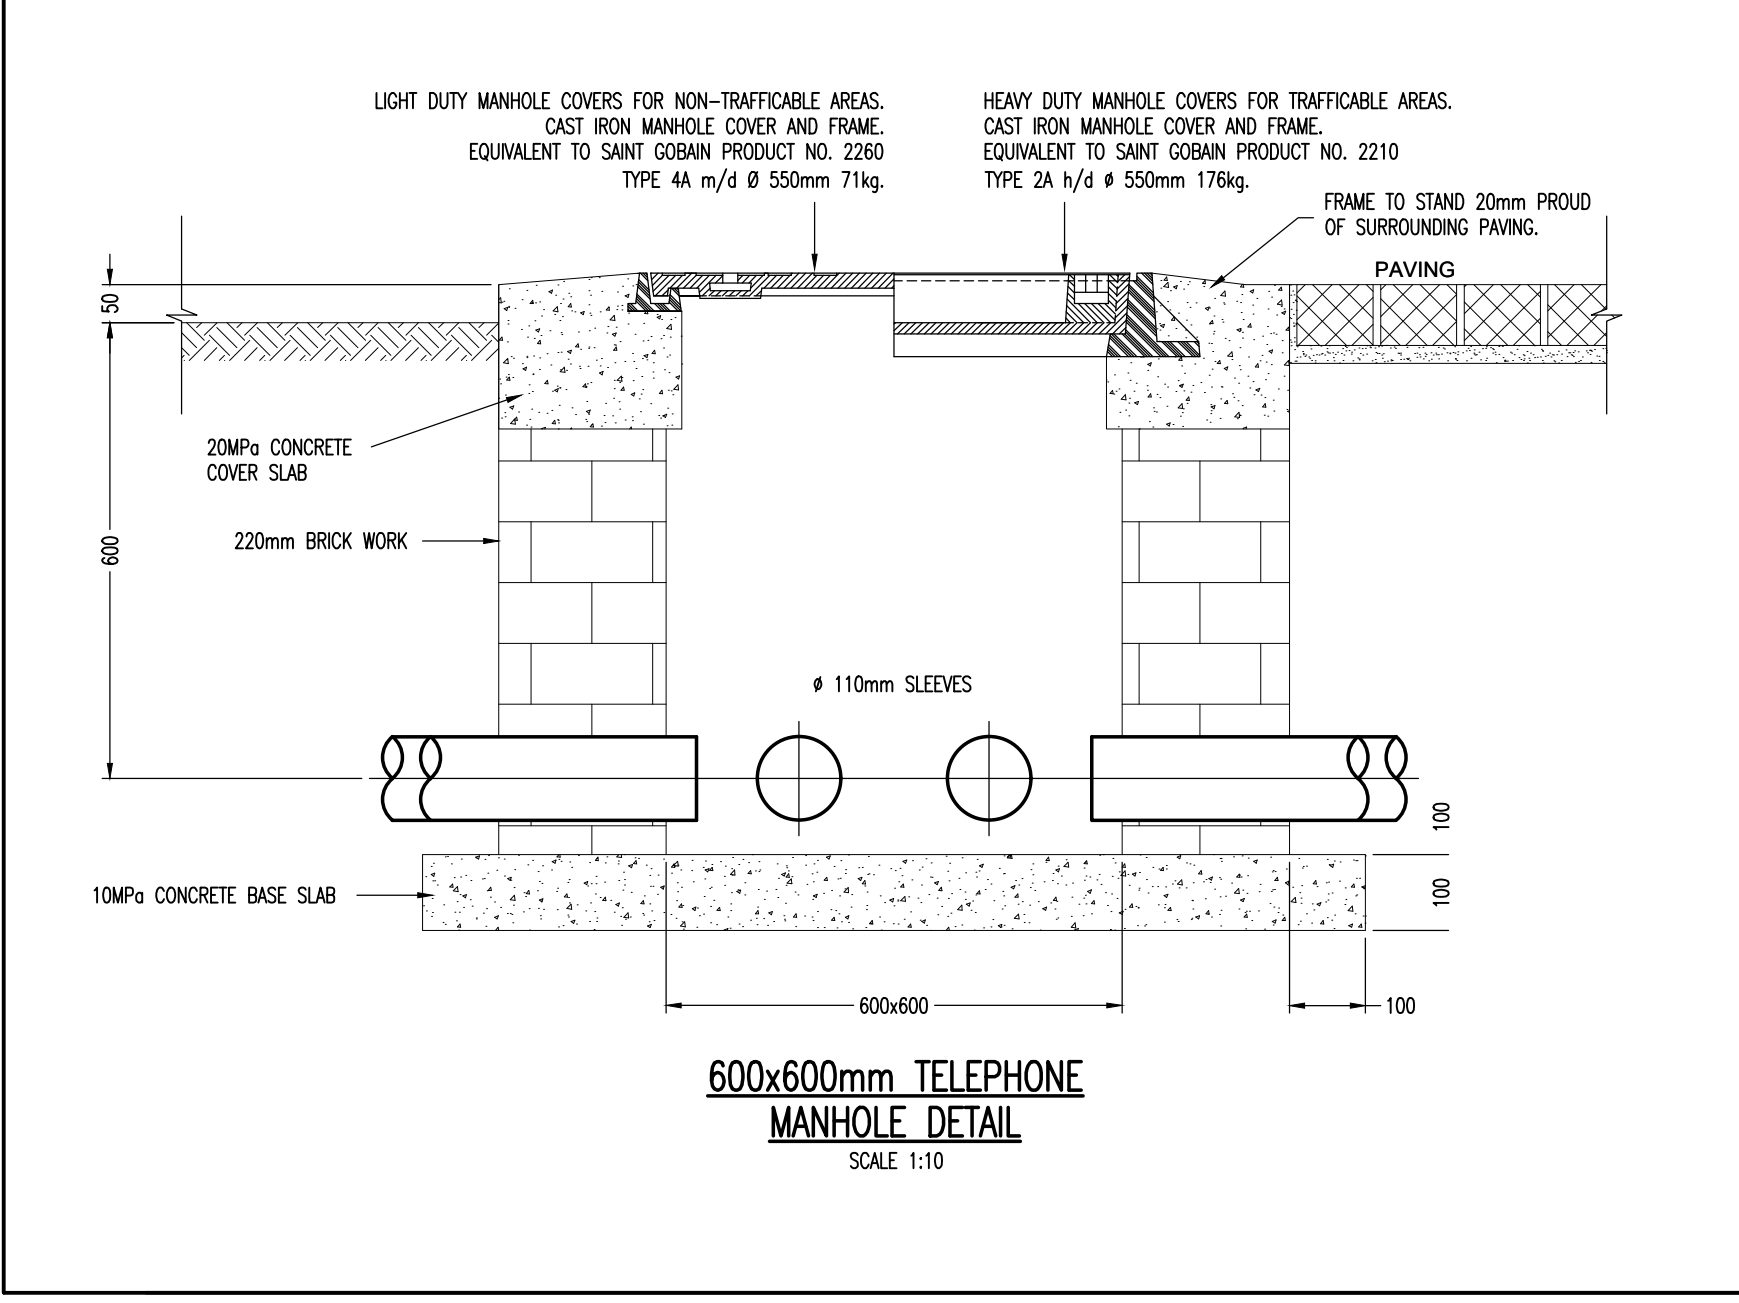

LEGEND		
SYMBOL	DESCRIPTION	QTY
	HEAVY DUTY 600x600mm TELEPHONE / DATA MANHOLE COMPLETE AS SPECIFIED (SEE DETAIL DRAWING).	
	PVC SLEEVE FOR VOICE/DATA SERVICES.	

DRAWING SCHEDULE		
5280/1001/EE-VD	VOICE AND DATA SITE PLAN	
5280/1002/EE-VD	GROUND FLOOR VOICE & DATA LAYOUT AND DISTRIBUTION FRAME DIAGRAM	